


Subject to field inspection


Reviewed for Code Compliance
Kitsap County Building Department
Kitsap County Fire Marshal

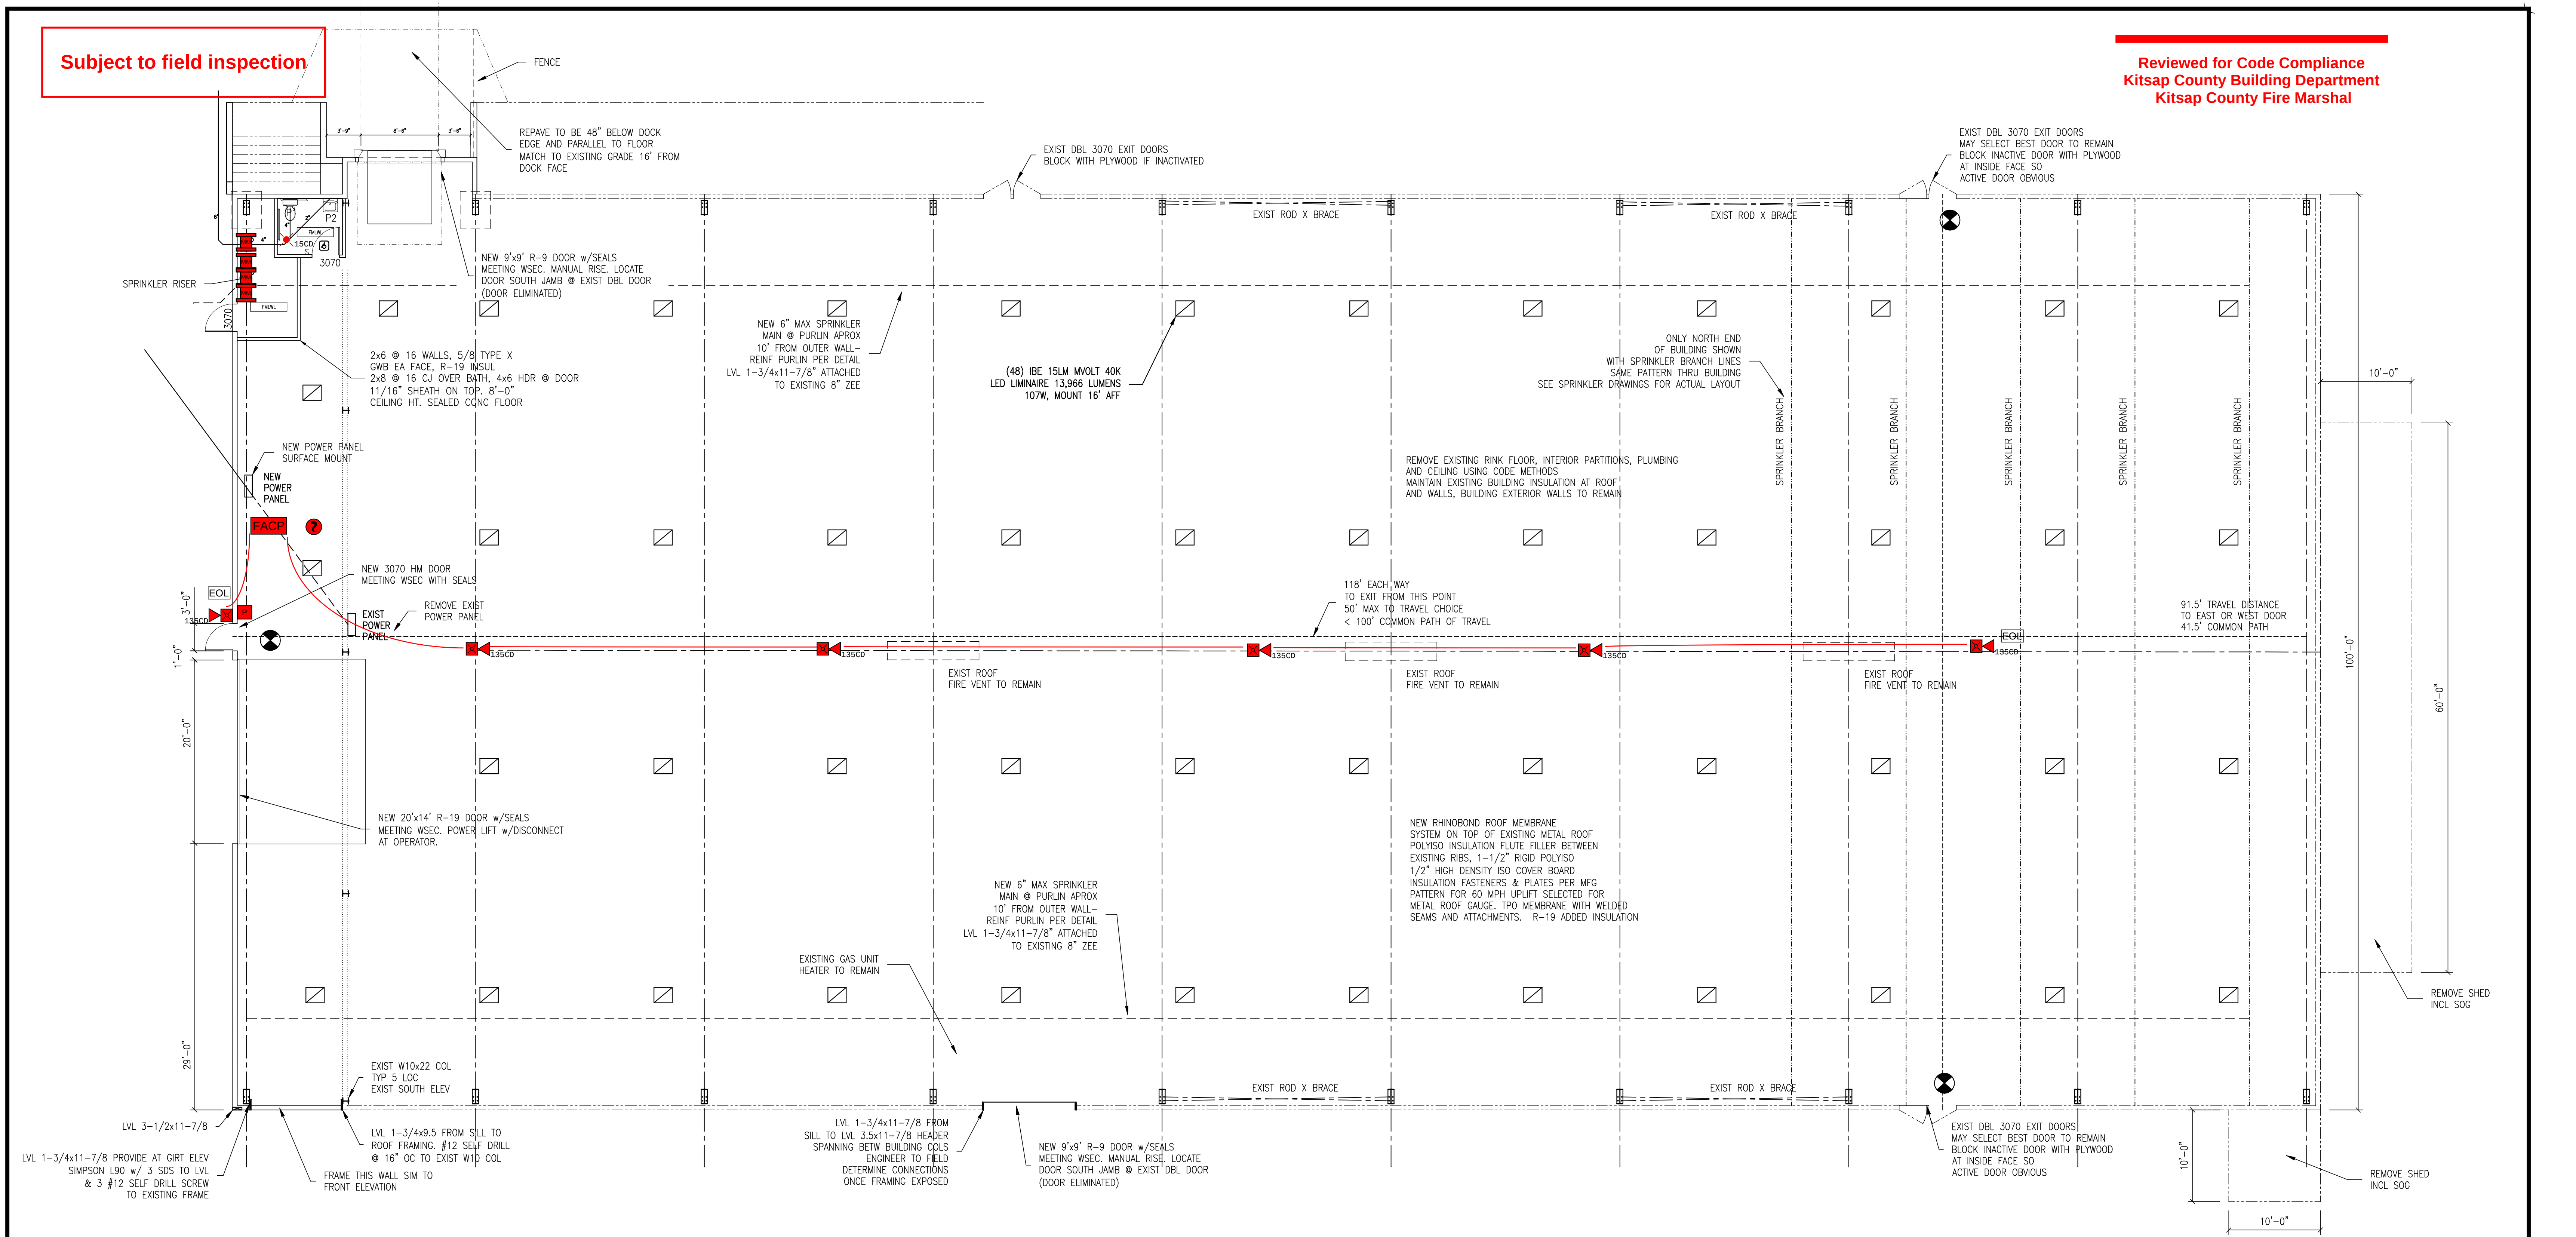

Legend

- FACP Fire Alarm Control Panel
- Input Module
- Pull Station
- Smoke Detector
- Strobe
- Horn/Strobe Combination

Riser

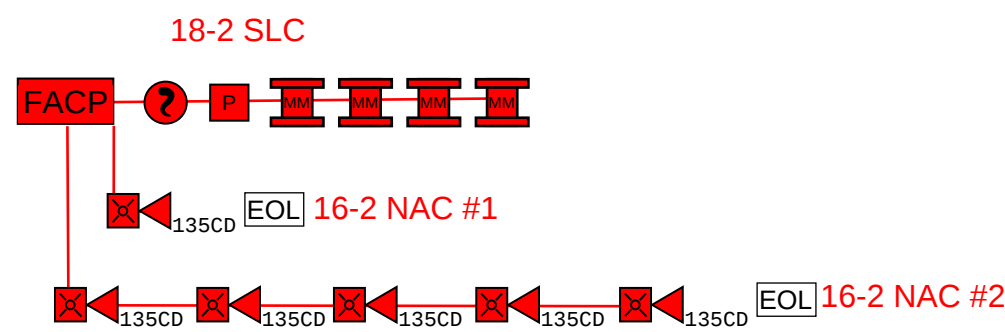

Designer

Kitsap Fire & Security
Isaac Harder
NICET III #140620
PO Box 2898 Poulsbo
WA 98370



Pro Design
J.G. Bartram, PE
P.O. BOX 699
TRACYTON, WA 98393
(360) 377-1026

UNITED MOVING & STORAGE
1740 NE FUSON RD, BREM 98311

DESIGN: BARTRAM	DRAWN: TN
DATE: 9-5-19	DWG. NO: 3

PROPOSED SOUTH ELEVATION
SCALE 1/8"=1'-0"

Permit Number: 21-00243